




TRANSFORMER ROOM PLAN
1/4" = 1'-0"

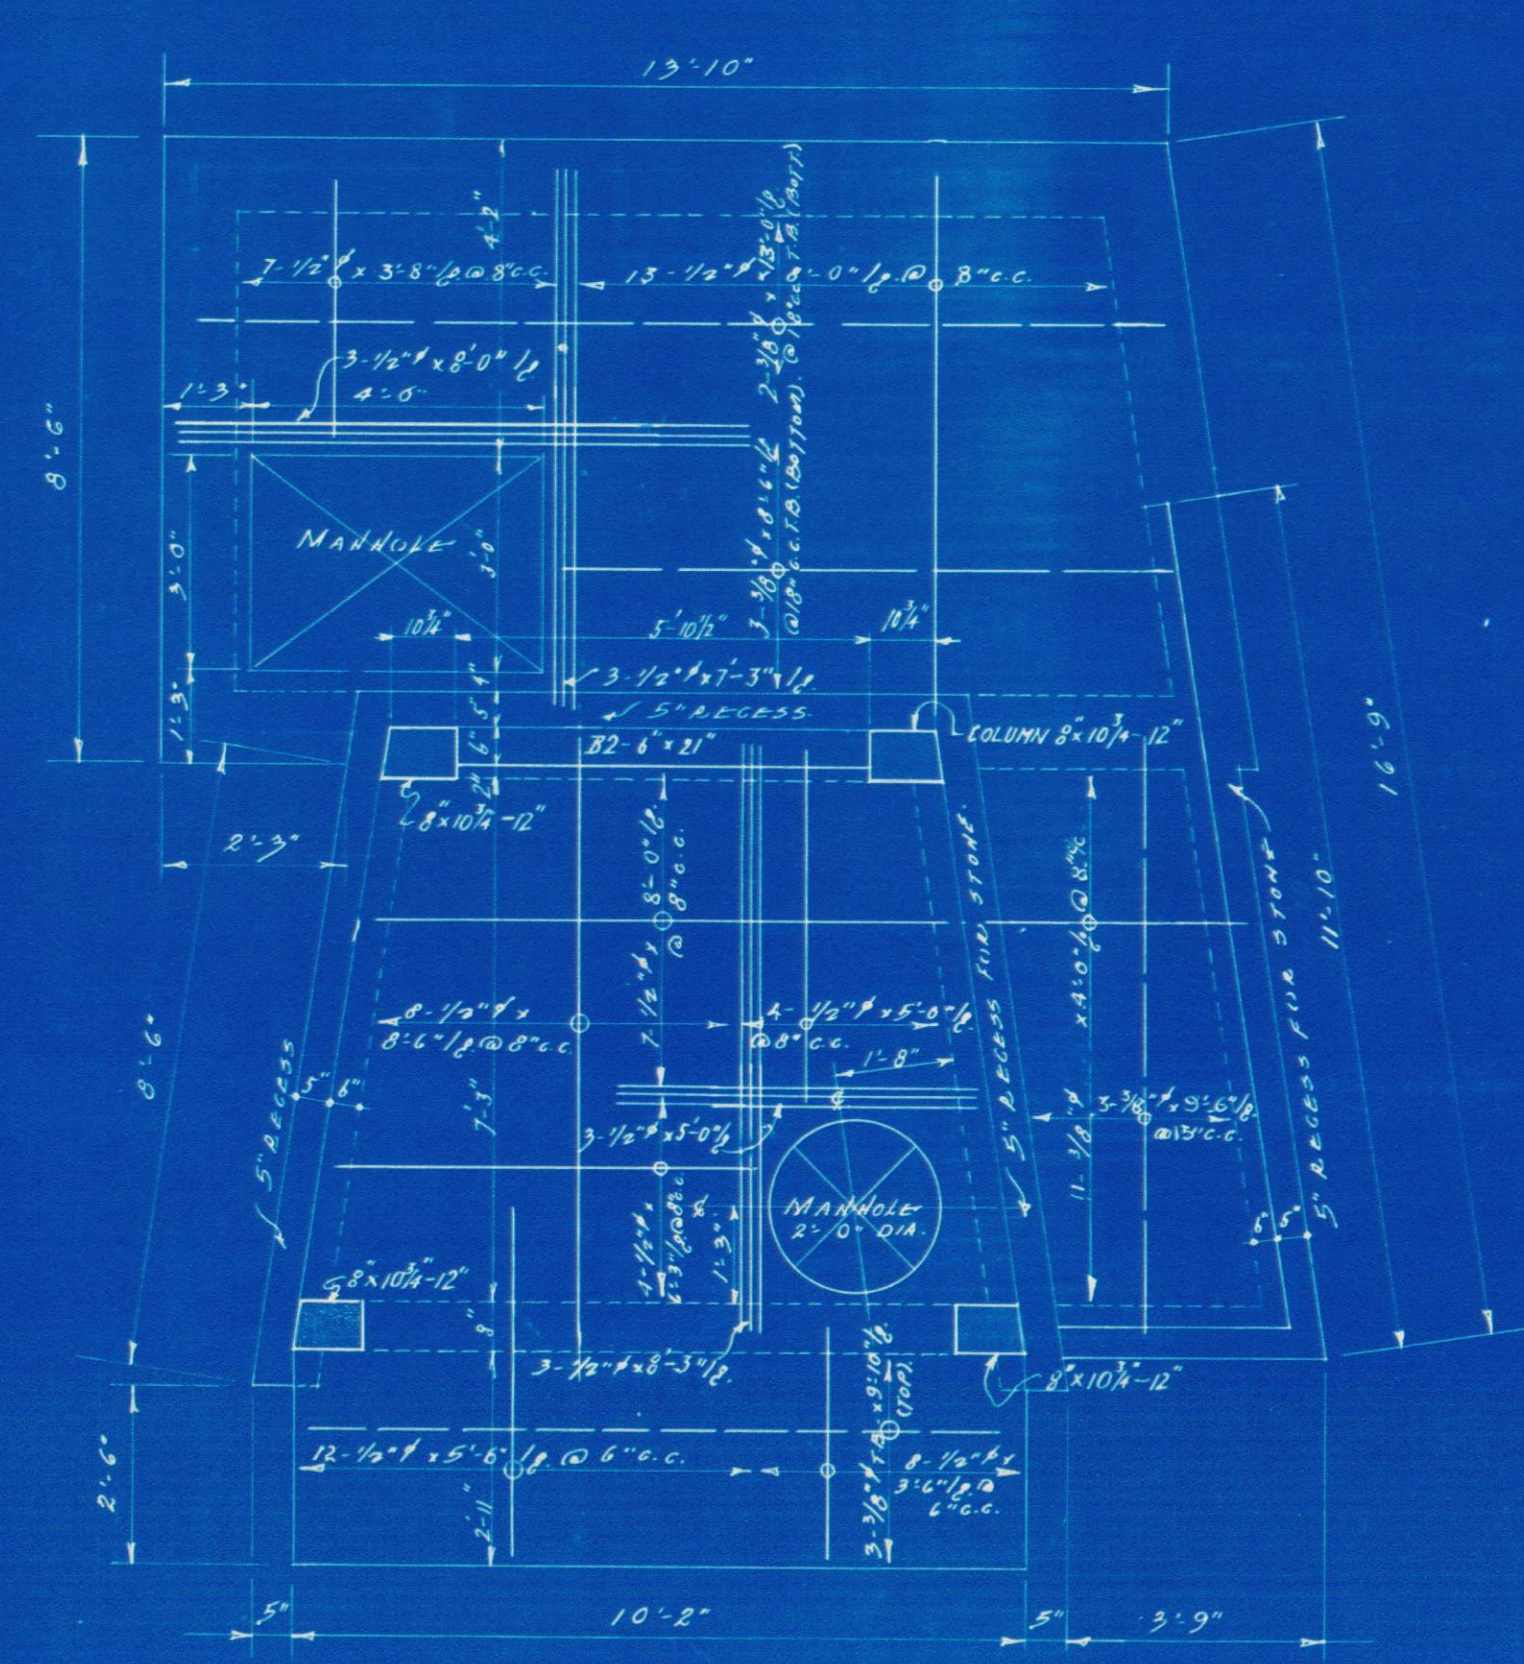


CONTROL ROOM & DIMMERS ROOM PLAN

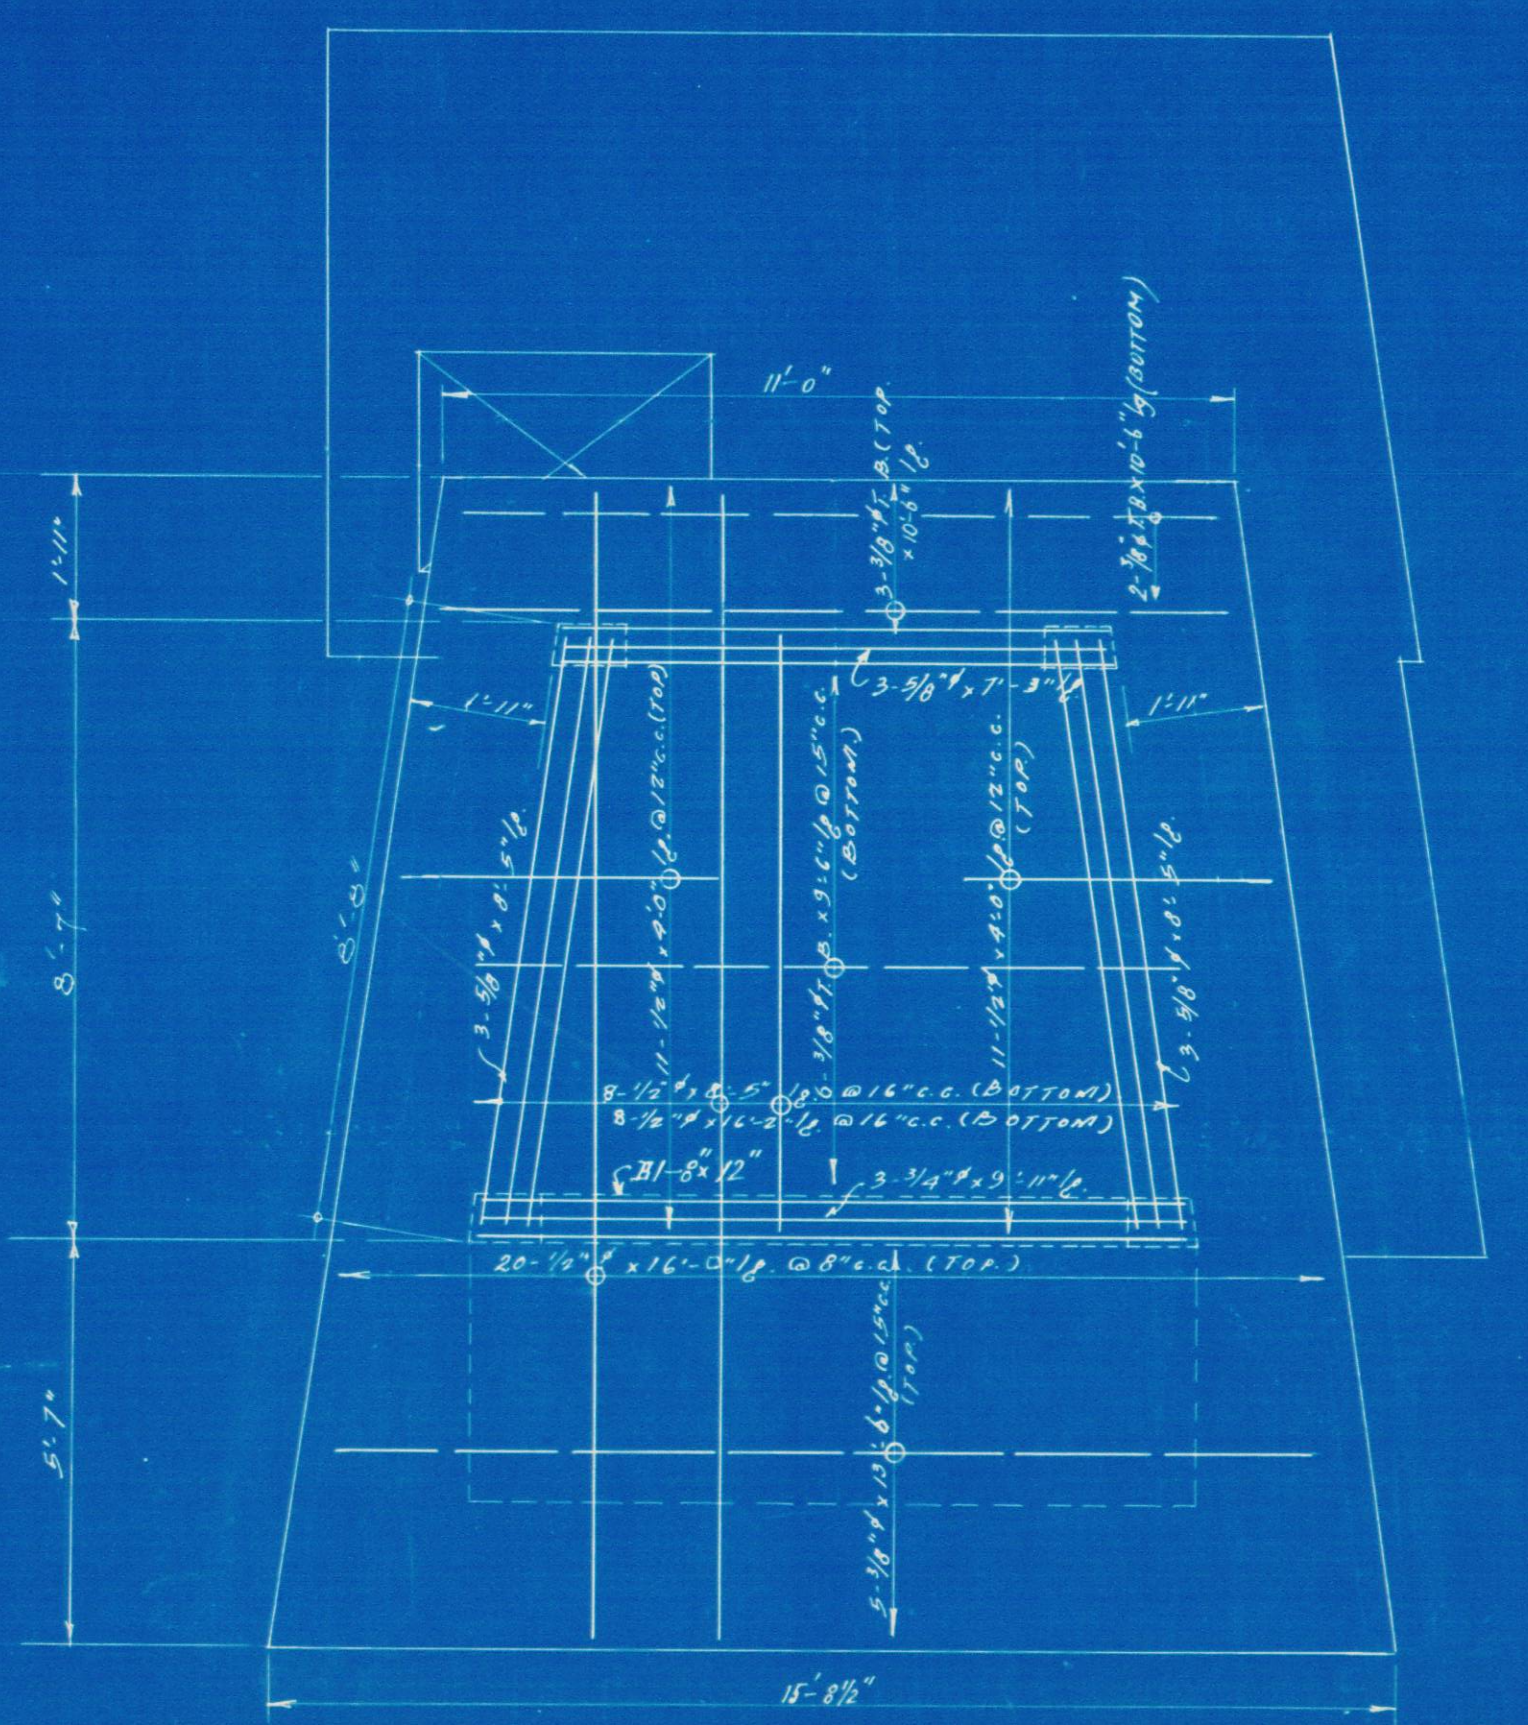


ROOF PLAN

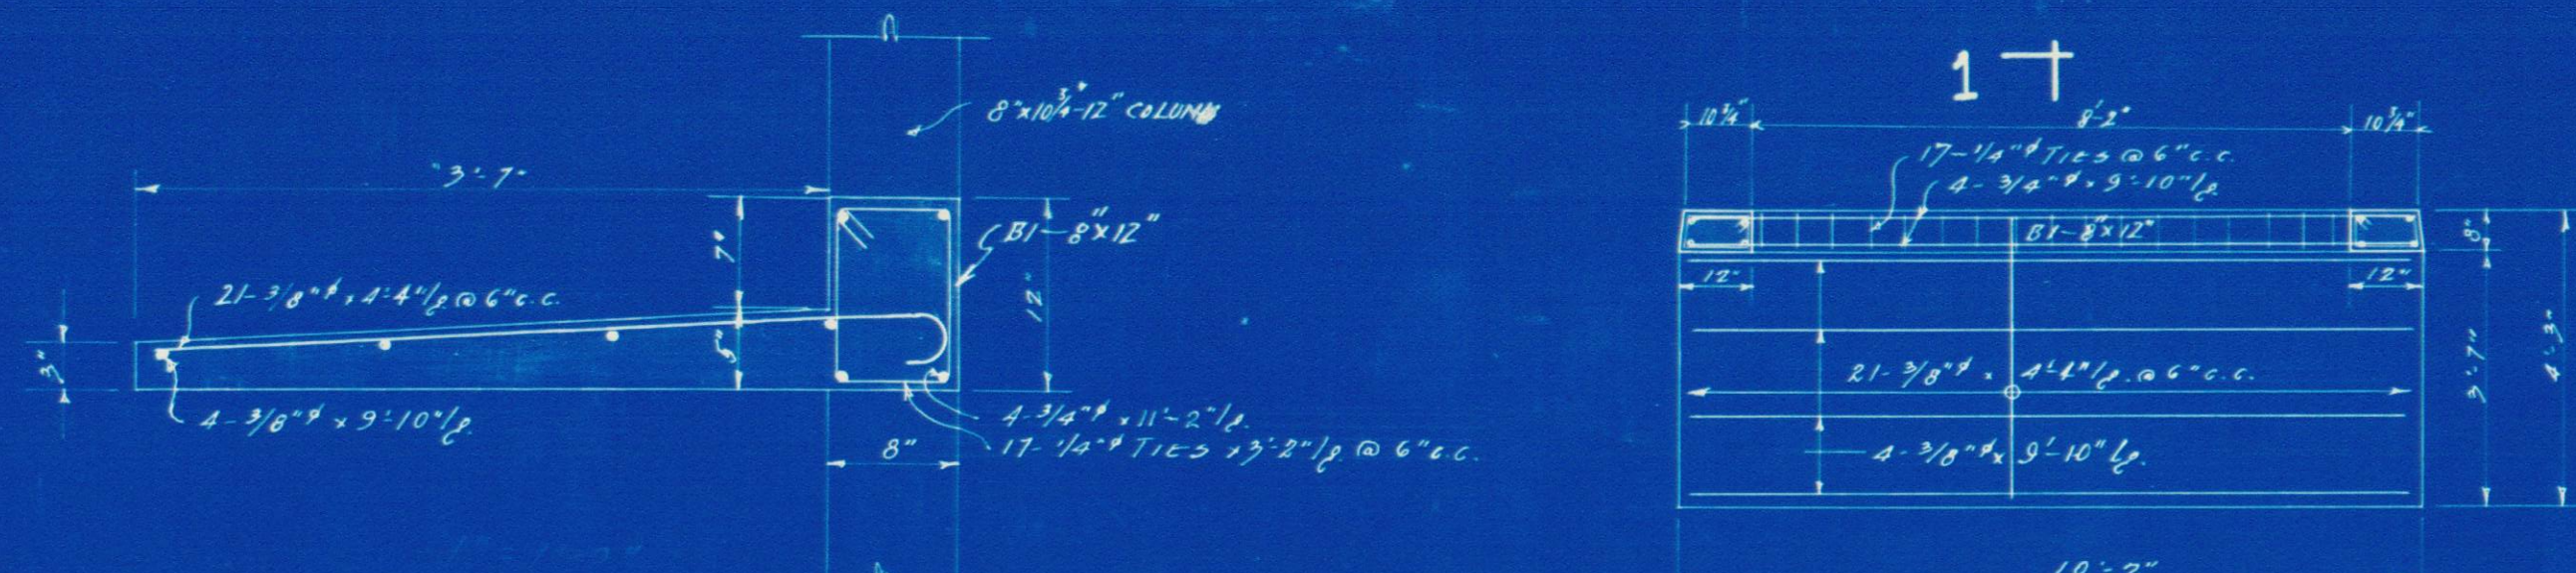


SECTION 1-1
10'-2"
DETAIL OF CANOPY
10'-2"

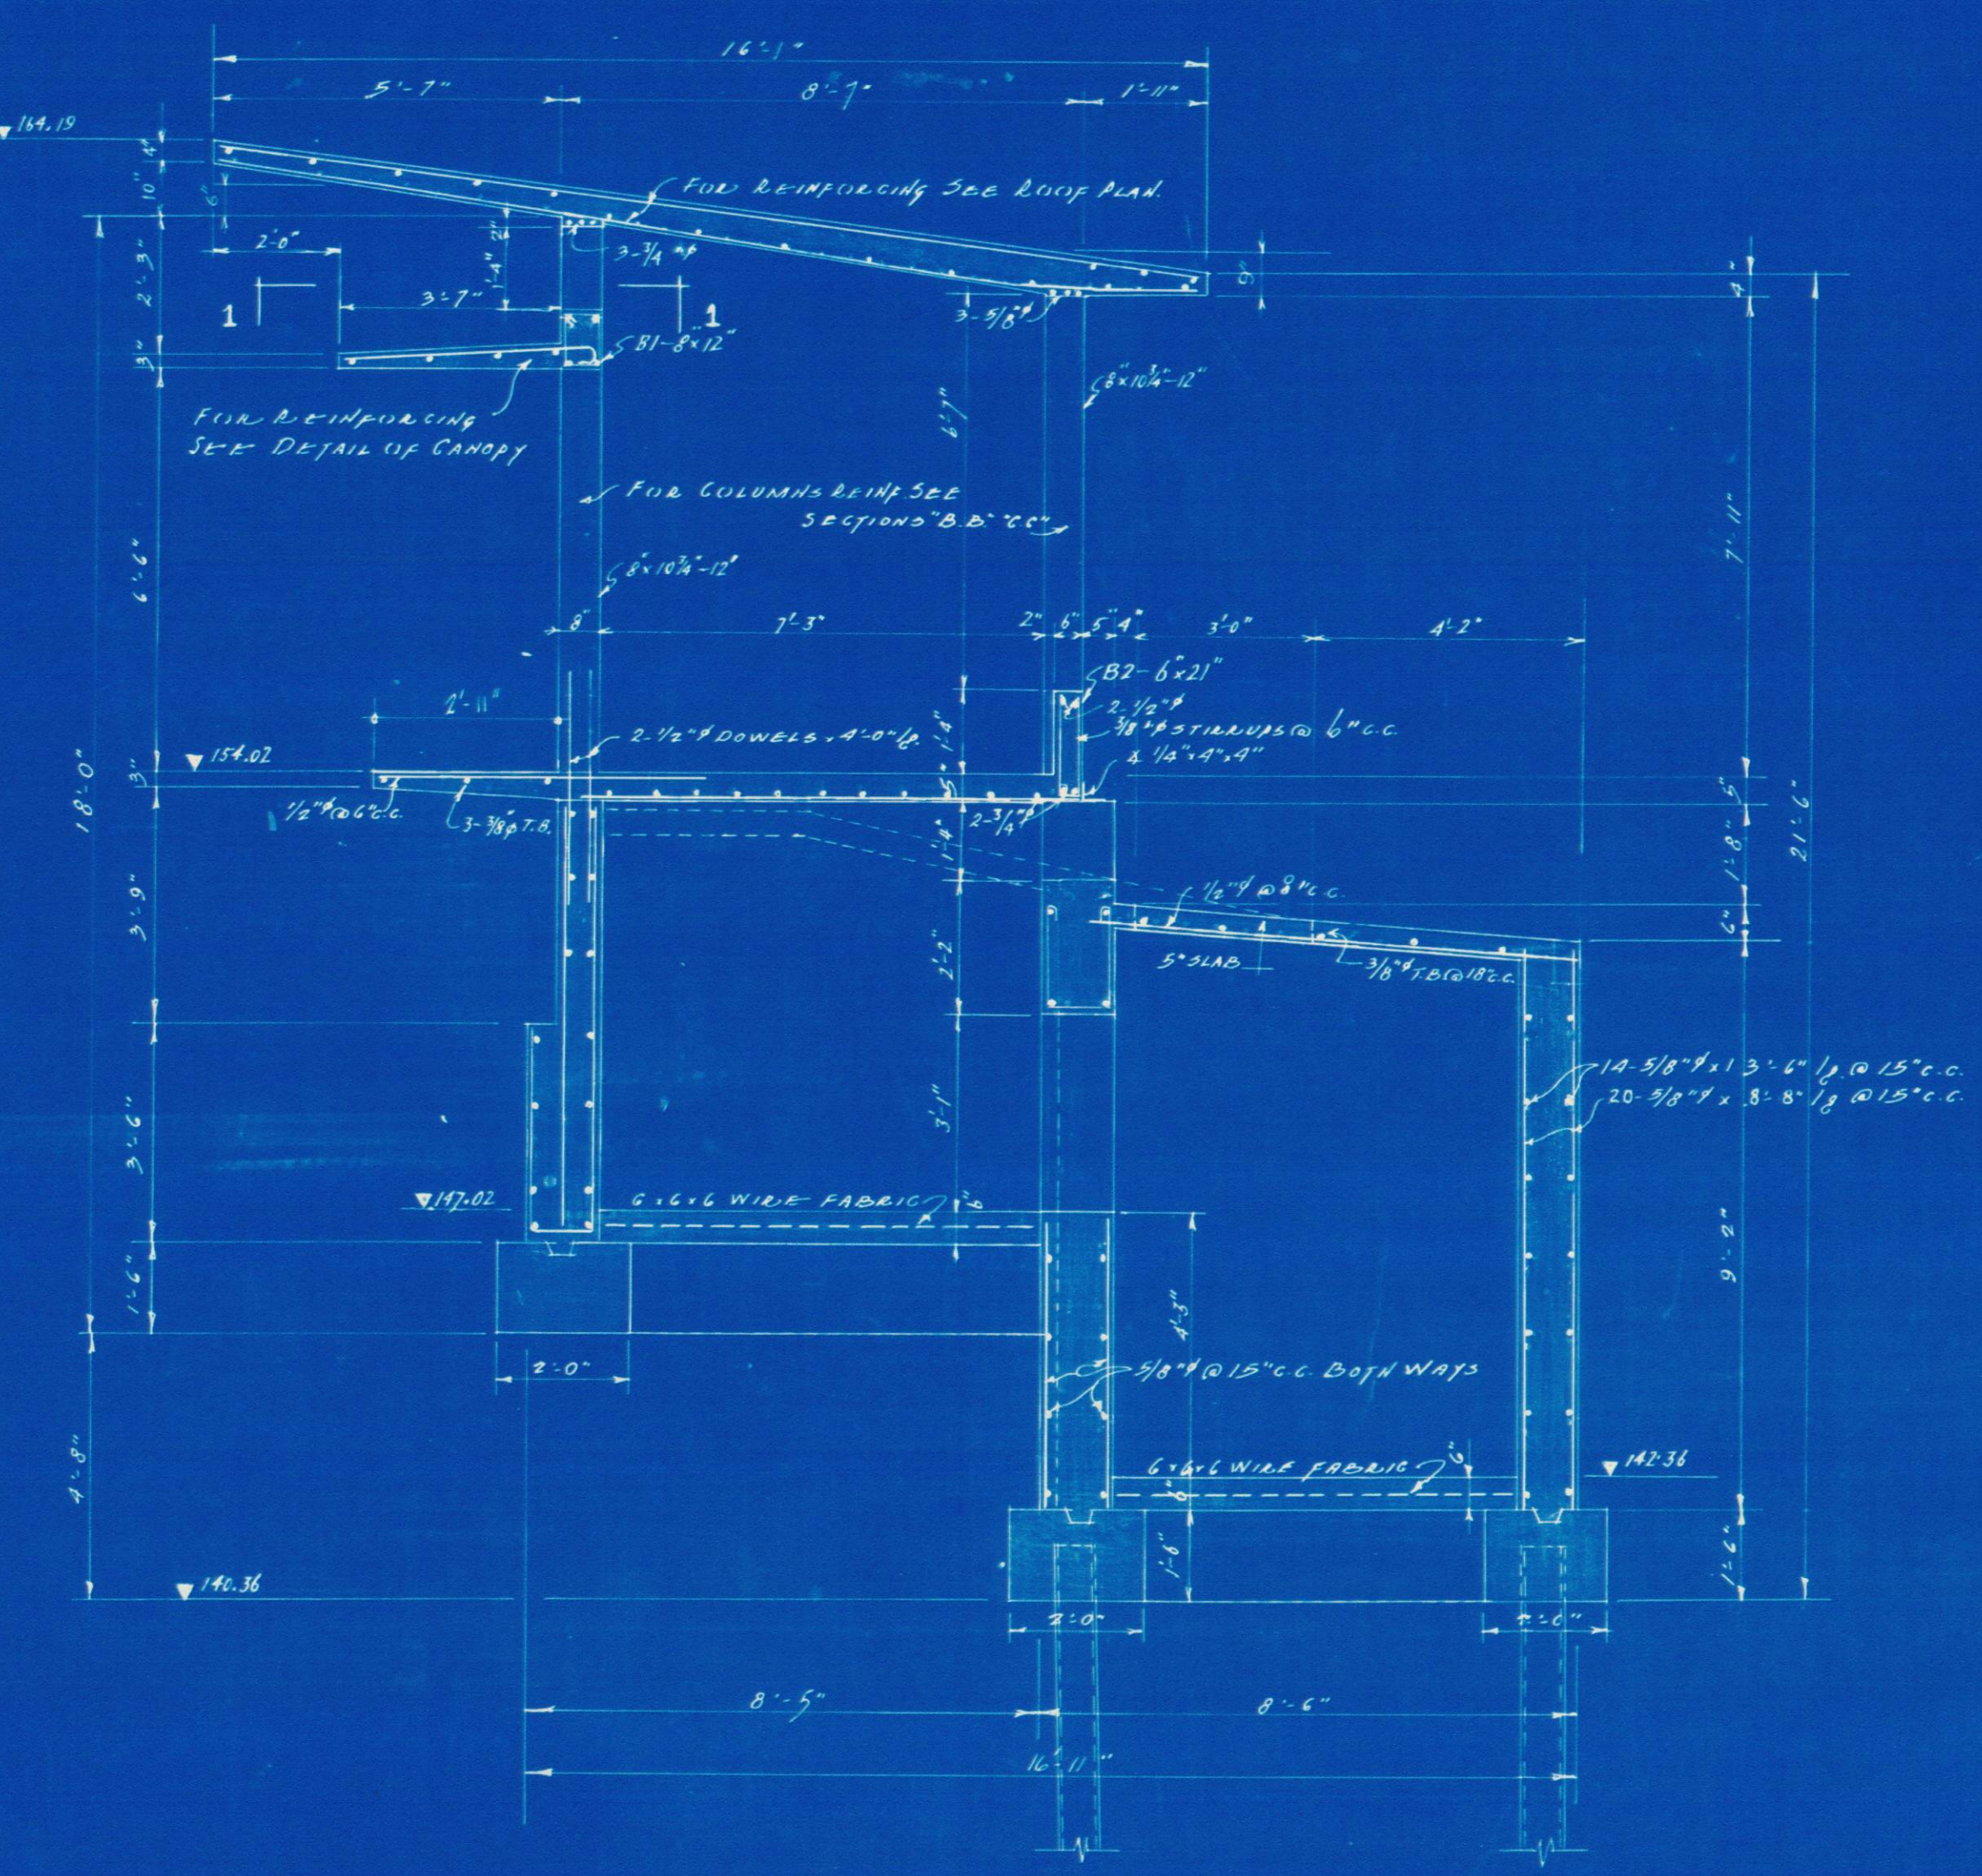

SECTION A-A
1/4" = 1'-0"

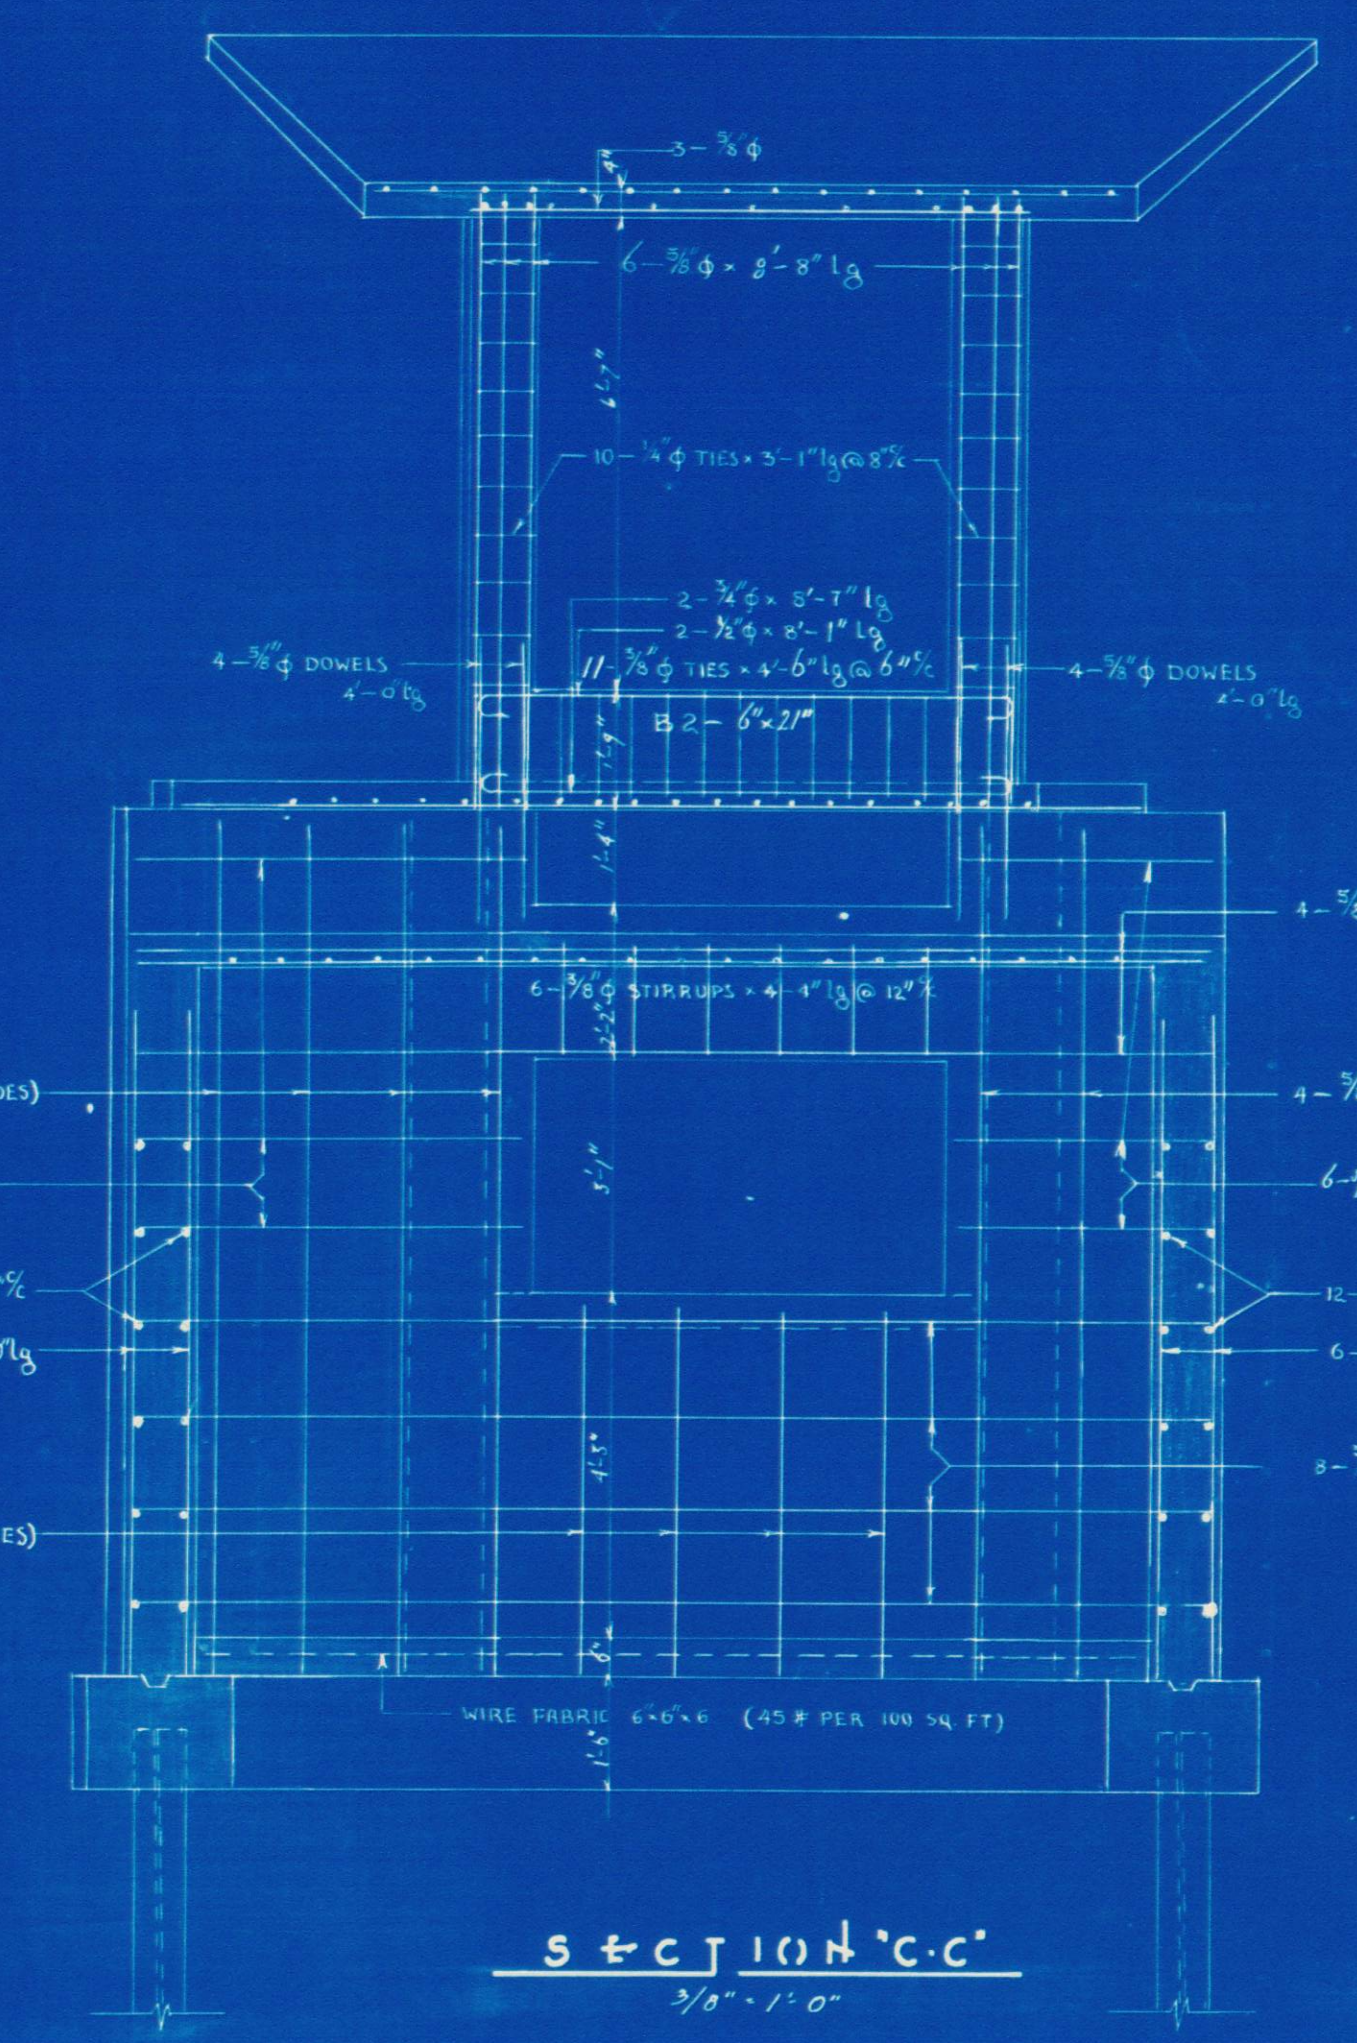

SECTION C-C
1/4" = 1'-0"

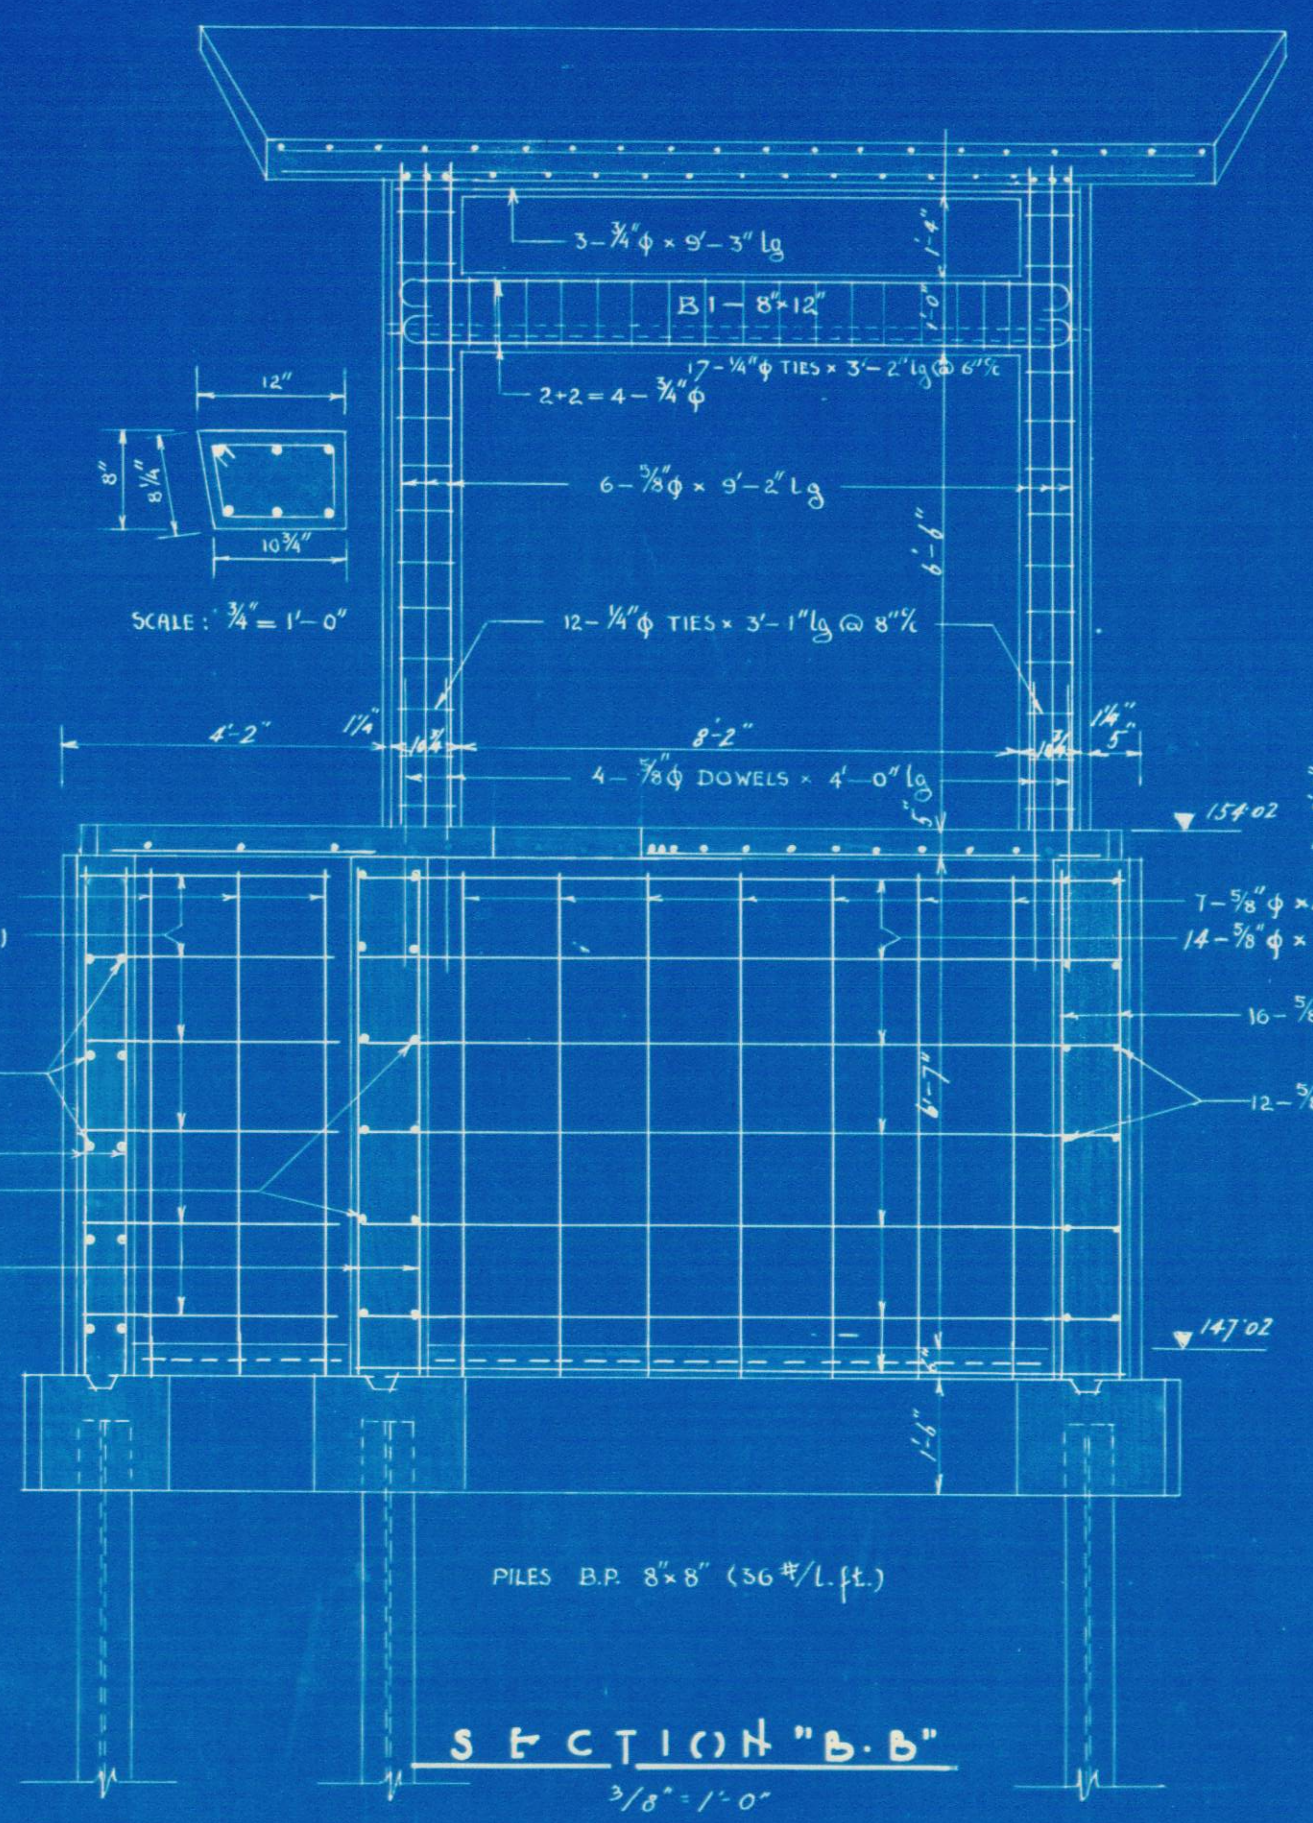

SECTION B-B
1/4" = 1'-0"

CERTIFIED			
OFFICIAL	FUNCTION	DEPARTMENT	DATE
EXECUTIVE COMMITTEE			
REVISIONS			
CITY OF MONTREAL			
TECHNICAL DIVISION	PLANS & FOUND. DES.	ARCHITECTS OFFICE	
OPEN-AIR THEATRE			
LAPONTAINE PARK			
REINFORCING OF CONTROL BLDG.			
CERTIFIED			
APPROVED	L. L. Allen		
DESIGNED			
DRAWN			
NO. 1107	2007	2007	2007